

# Miami International Boat Show


February 11-15, 2010  
 Miami Beach Convention Center  
 Miami, FL  
 Street & Parking Lot

*\*This floor plan is subject to fire marshal approval.*



139 Campanelli Drive  
 Middleborough, MA 02346  
 Phone: 508.946.8500  
 Fax: 508.923.1409

- Account Executive: Pam Thornton
- Revision Date: 01.21.10
- Rev. #11
- Drawn By: Meghan Morton
- Scale: Fit to page

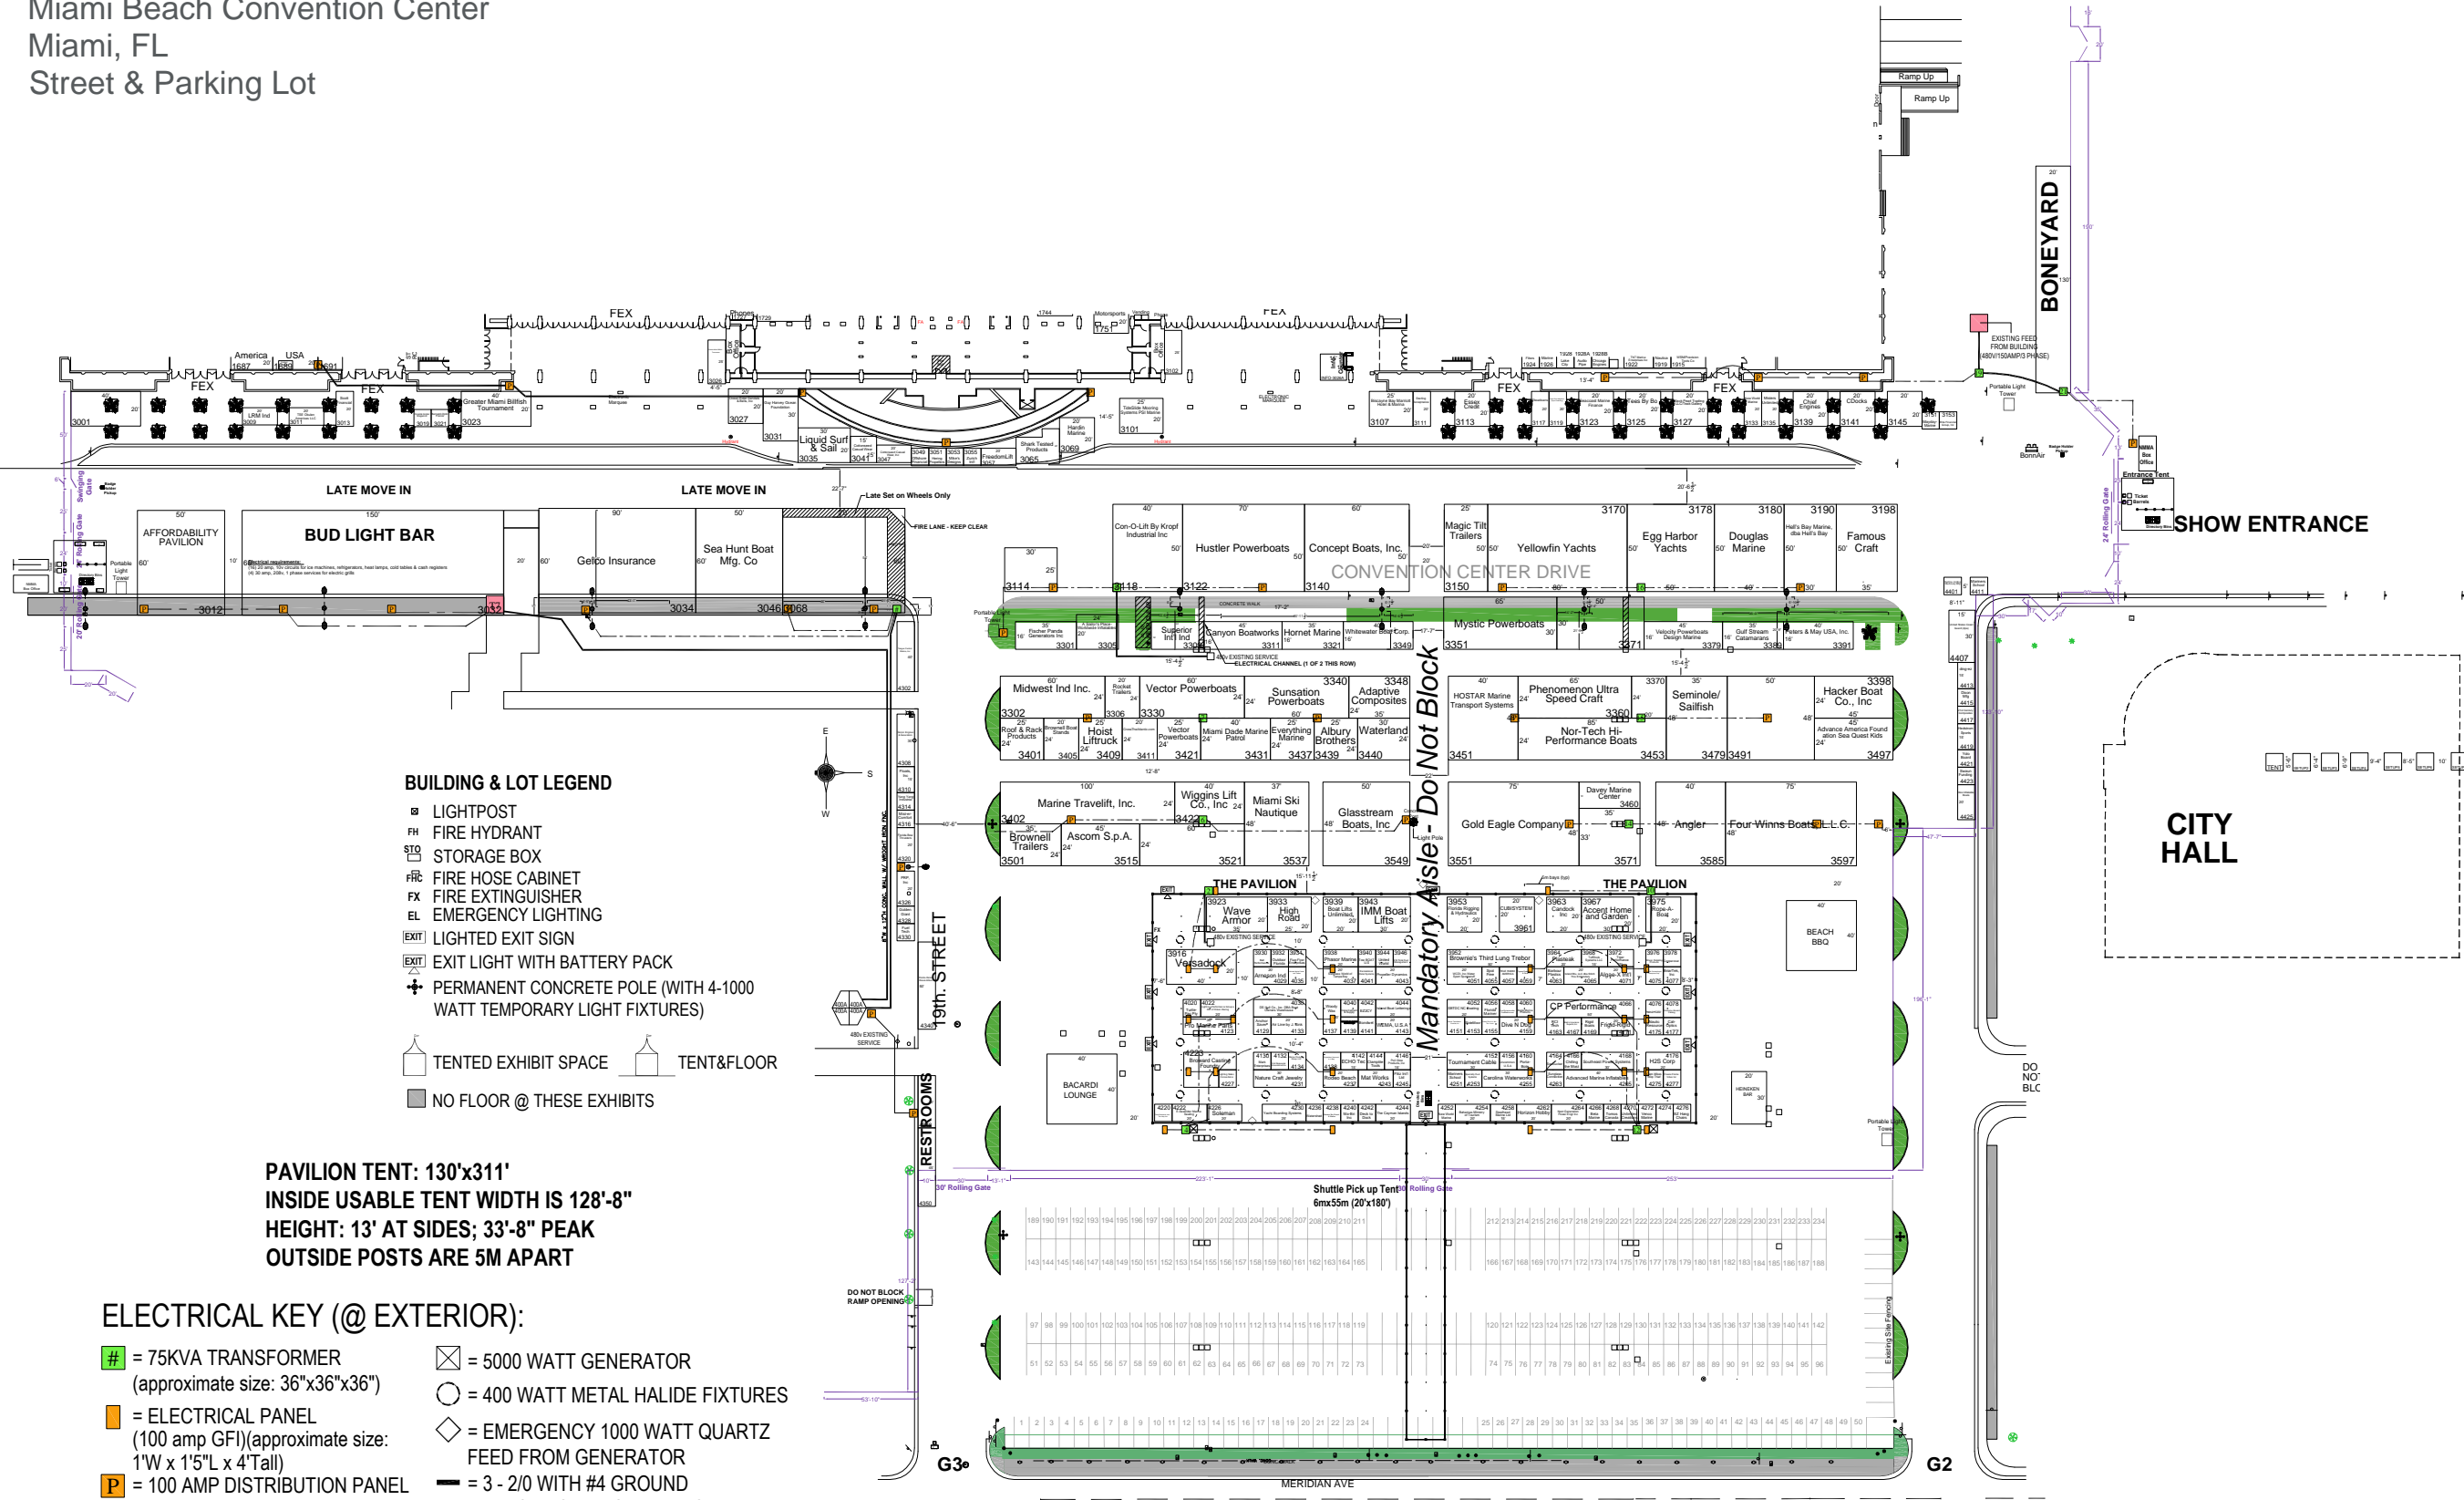

### BUILDING & LOT LEGEND

- LIGHTPOST
- FH FIRE HYDRANT
- STB STORAGE BOX
- FHC FIRE HOSE CABINET
- FX FIRE EXTINGUISHER
- EL EMERGENCY LIGHTING
- EXIT LIGHTED EXIT SIGN
- EXIT EXIT LIGHT WITH BATTERY PACK
- ⊕ PERMANENT CONCRETE POLE (WITH 4-1000 WATT TEMPORARY LIGHT FIXTURES)
- ▭ TENTED EXHIBIT SPACE
- ▭ TENT&FLOOR
- ▭ NO FLOOR @ THESE EXHIBITS

**PAVILION TENT: 130'x311'**  
**INSIDE USABLE TENT WIDTH IS 128'-8"**  
**HEIGHT: 13' AT SIDES; 33'-8" PEAK**  
**OUTSIDE POSTS ARE 5M APART**

### ELECTRICAL KEY (@ EXTERIOR):

- # = 75KVA TRANSFORMER (approximate size: 36"x36"x36")
- = ELECTRICAL PANEL (100 amp GFI)(approximate size: 1'W x 1'5"L x 4'Tall)
- P = 100 AMP DISTRIBUTION PANEL
- T7 = 150KVA TRANSFORMER
- ⊗ = 5000 WATT GENERATOR
- = 400 WATT METAL HALIDE FIXTURES
- ◇ = EMERGENCY 1000 WATT QUARTZ FEED FROM GENERATOR
- = 3 - 2/0 WITH #4 GROUND
- = ELECTRICAL DISTRIBUTION (4/4)(approximate size: 2" round)
- ▨ = NON-USABLE AREA, ELE CHANNELS @ EXTERIOR

**Expocad Event Backup as of 01.21.10**

**Disclaimer**  
 Every effort has been made to ensure the accuracy of all information contained on this floor plan. However no warranties, either expressed or implied are made with respect to this floor plan. If the location of building columns, utilities or other architectural components of the facility is a consideration in the construction or usage of an exhibit, it is the sole responsibility of the exhibitor to physically inspect the facility to verify all dimensions and locations.