

Miami International Boat Show


February 11-15, 2010
 Miami Beach Convention Center
 Miami, FL
 Exhibit Halls A-D & Street Level Ballrooms

*This floor plan is subject to fire marshal approval.



139 Campanelli Drive
 Middleborough, MA 02346
 Phone: 508.946.8500
 Fax: 508.923.1409

- Account Executive: Pam Thornton
- Revision Date: 01.21.10
- Rev. # 14
- Drawn By: Meghan Morton
- Scale: Fit to page

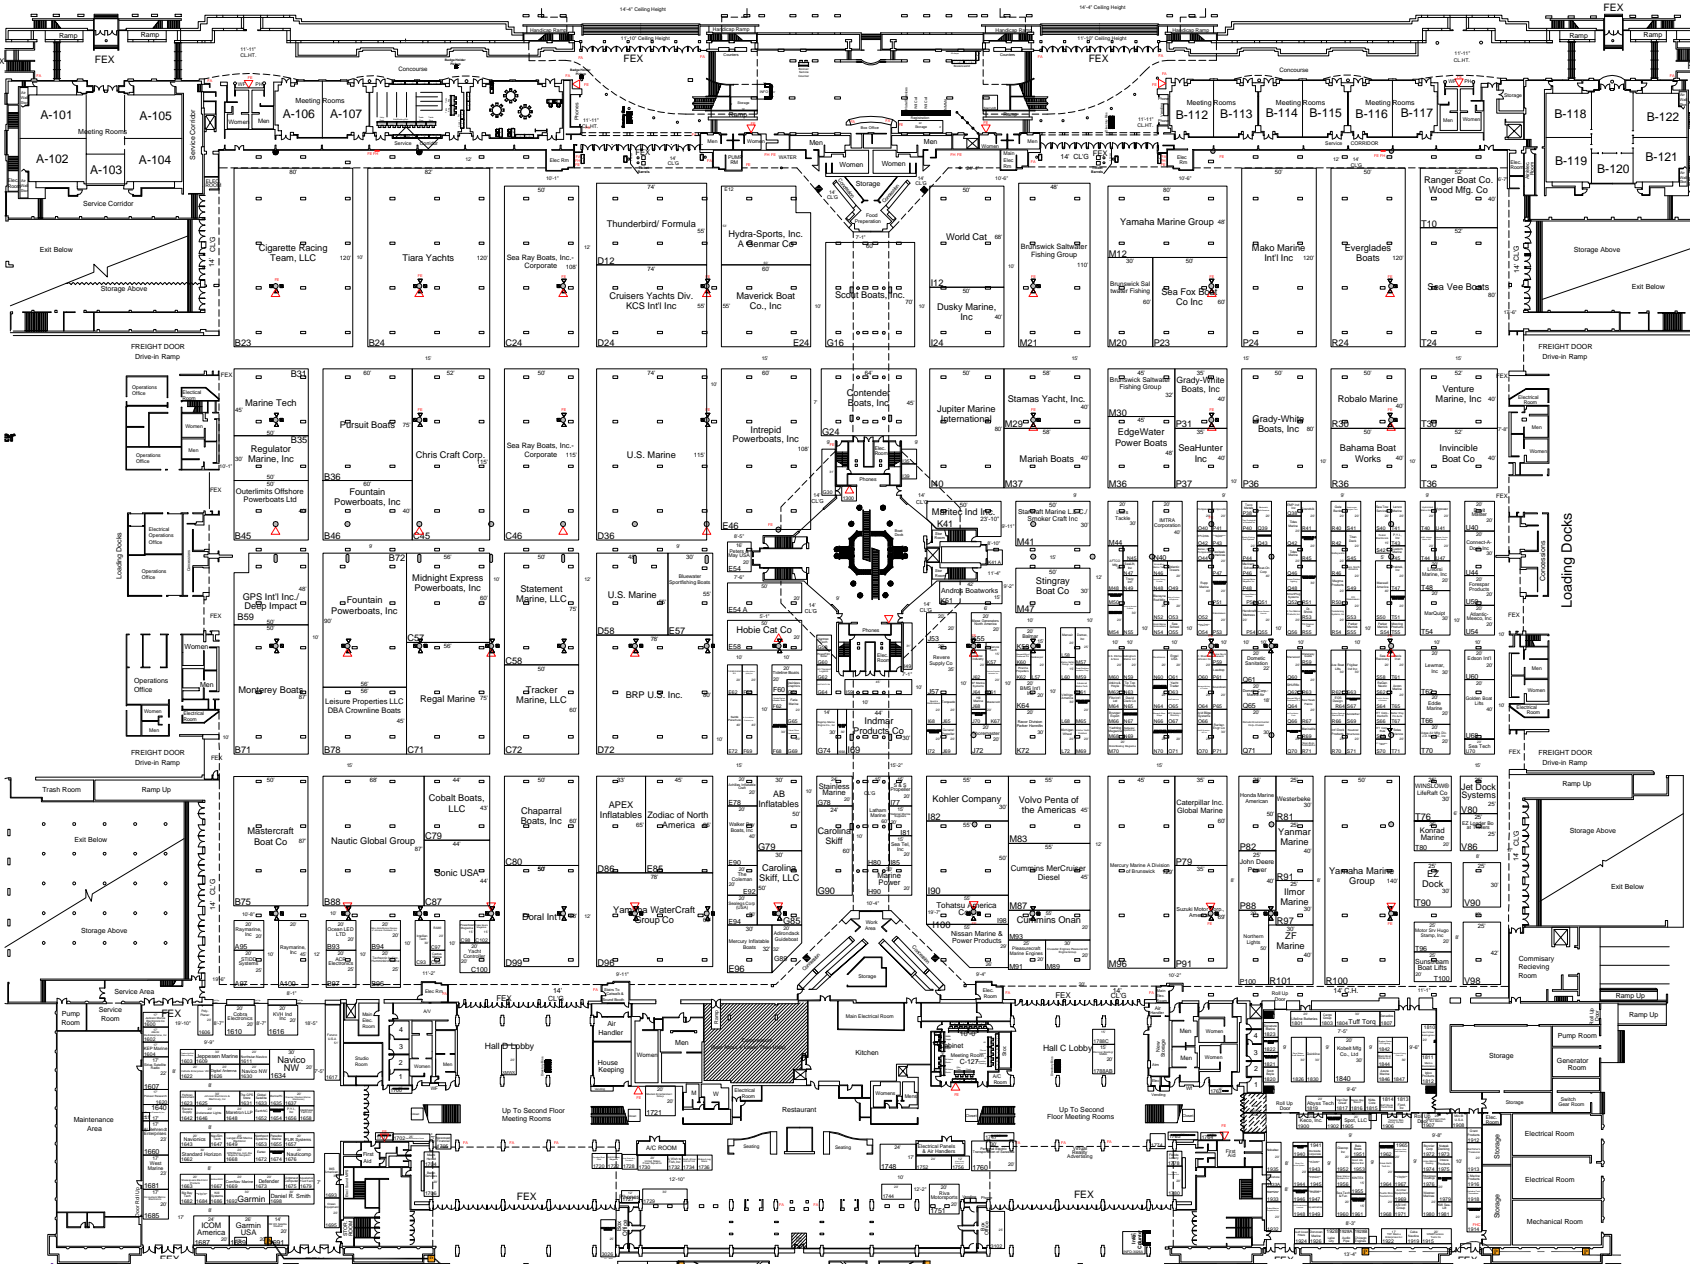

Legend

Telephone
 available Throughout Exhibit Hall

ceiling Height
 35' Throughout Exhibit Hall Except As Indicated

FE - Fire Extinguisher
 FEX - Fire Exit
 FHC - Fire Hose Cabinet

□ - 1"8" X 3"4" Electrical
 plumbing & Telephone Floor Box

▭ - 24" x 48" Rectangular Column

○ - 42" Diameter Column

○ - 24" X 66" Oval Columns
 Along East Wall Of Hall D

■ - 2' X 2' Floor Drain

▲ - Water & Compressed Air
 Access On Column

*Booths should stay min. of 1' off the columns.

Disclaimer
 Every effort has been made to ensure the accuracy of all information contained on this floor plan. However no warranties, either expressed or implied are made with respect to this floor plan. If the location of building columns, utilities or other architectural components of the facility is a consideration in the construction or usage of an exhibit, it is the sole responsibility of the exhibitor to physically inspect the facility to verify all dimensions and locations.